


# CLANDESTINE DESIGN GROUP

**BCC DS**  
 RECEIVED  
 25/06/2026  
 APPLICATION REF  
 A006967005

SCHEDULE OF DRAWINGS		
DWG. NO.	TITLE.	DATE.
CDG- 100/ 01	TITLE PAGE / SITE PLAN	22-11-25
CDG- 101/ 01	EXISTING FLOOR PLAN GROUND LEVEL	19-11-25
CDG- 102/ 01	EXISTING FLOOR PLAN LEVEL 1	26-11-25
CDG- 103/ 01	DEMOLITION FLOOR PLAN GROUND LEVEL	22-11-25
CDG- 104/ 01	DEMOLITION FLOOR PLAN LEVEL 1	22-11-25
CDG- 105/ 02	PROPOSED FLOOR PLAN GROUND LEVEL	24-11-25
CDG- 106/ 03	PROPOSED FLOOR PLAN LEVEL 1	24-11-25
CDG- 107/ 01	PARTITION PLAN GROUND LEVEL	28-11-25
CDG- 108/ 01	PARTITION PLAN LEVEL 1	28-11-25
CDG- 109/ 01	REFLECTED CEILING PLAN GROUND LEVEL	08-12-25
CDG- 110/ 01	REFLECTED CEILING PLAN LEVEL 1	08-12-25
CDG- 111/ 01	ELECTRICAL PLAN GROUND LEVEL	08-12-25
CDG- 112/ 01	ELECTRICAL PLAN LEVEL 1	08-12-25
CDG- 113/ 01	PLUMBING PLAN GROUND LEVEL AND LEVEL 1	08-12-25
CDG- 114/ 01	ELEVATION REFERENCE PLAN - KITCHEN GROUND LEVEL KITCHEN GROUND LEVEL - ELEVATION 01 AND 2	09-12-25
CDG- 115/ 01	ELEVATION REFERENCE PLAN - KITCHEN LEVEL 1 KITCHEN LEVEL 1 - ELEVATION 01	09-12-25
CDG- 116/ 01	ELEVATION REFERENCE PLAN - BATHROOM GROUND LEVEL	09-12-25
CDG- 117/ 01	PWD BATHROOM GROUND LEVEL - ELEVATION 01,02,03 AND 04	09-12-25
CDG- 118/ 01	ELEVATION REFERENCE PLAN AMBULANT TOILET 1 AND 2 LEVEL 1	09-12-25
CDG- 119/ 01	ELEVATION 01, 02 AND 03 - AMBULANT TOILET 1	09-12-25
CDG- 120/ 01	ELEVATION 01, 02, 03 AND 04 - AMBULANT TOILET 2	09-12-25
CDG- 121/ 01	FLOOR FINISHES PLAN GROUND LEVEL	27-11-25
CDG- 122/ 01	FLOOR FINISHES PLAN LEVEL 1	27-11-25
CDG- 123/ 01	WALL FINISHES PLAN GROUND LEVEL	27-11-25
CDG- 124/ 01	WALL FINISHES PLAN LEVEL 1	27-11-25
CDG- 125/ 01	MECHANICAL GROUND LEVEL	09-12-25
CDG- 126/ 01	MECHANICAL LEVEL 1	09-12-25
CDG- 127/ 01	PROPOSED POSTS, BEAMS AND POLE PLATES	11-12-25
CDG- 128/ 01	PROPOSED JOIST SETOUT	11-12-25
CDG- 129/ 01	PROPOSED BALUSTRADE, HANDRAIL AND STAIRS	11-12-25
CDG- 130/ 01	GENERAL CONSTRUCTION NOTES	19-11-25

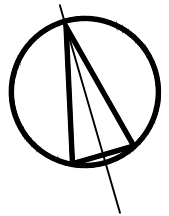

27 BALACLAVA STREET, WOOLLOONGABBA  
BRISBANE QLD 4102

- THESE PLANS REMAIN THE PROPERTY OF IMPACT FITOUTS AND SHOULD NOT BE COPIED OR DISTRIBUTED WITHOUT PRIOR CONSENT. ALL DRAWINGS ARE SUBJECT TO COPYRIGHT LAWS.

- THESE PLANS ARE NOT TO BE USED FOR CONSTRUCTION PURPOSES AND ARE ONLY A GUIDELINE FOR THE SERVICES REQUIRED. EG- HYDRAULICS, LIGHTING, ELECTRICAL, ETC.

- ONLY WRITTEN MEASUREMENTS SHOULD BE CONSIDERED. DO NOT SCALE OFF THE PLANS. PLEASE CALL TO VERIFY DIMENSIONS IF YOU ARE UNSURE.

- PLANS DRAWN TO FIT ON A3 PAPER SIZE ONLY. EMAILED, PHOTOCOPIED, OF PDF FORMATTED DRAWINGS MAY NOT BE TO SCALE.

- CONTRACTORS SHOULD VERIFY SITE MEASUREMENTS AND CONDITIONS BEFORE STARTING WORKS. ALL WORKS TO COMPLY WITH THE RELEVANT AUSTRALIAN STANDARDS AND THE RELEVANT LOCAL AUTHORITY LAWS.

- DRAWINGS SUBJECT TO CHANGE AT ANYTIME WITHOUT NOTIFICATION.

REVISIONS:			
DATE:	ISSUE:	AMENDMENT:	APPROVED BY:

SCALE: NTS ON A3 PAPER ONLY

DRAWN BY: LD DATE: 11-12-2025

CLIENT:	CLANDESTINE DESIGN GROUP
PROJECT:	CLANDESTINE DESIGN GROUP
SITE ADDRESS:	27 BALACLAVA STREET WOOLLOONGABBA BRISBANE QLD 4102
TITLE:	SITE PLAN




E : [info@impactfitouts.com.au](mailto:info@impactfitouts.com.au)  
P: 0413 530 560

DRAWING NO:	CDG-100	ISSUE:	01
-------------	---------	--------	----



**BCC DS**  
**RECEIVED**  
 25/06/2026  
**APPLICATION REF**  
 A006967005

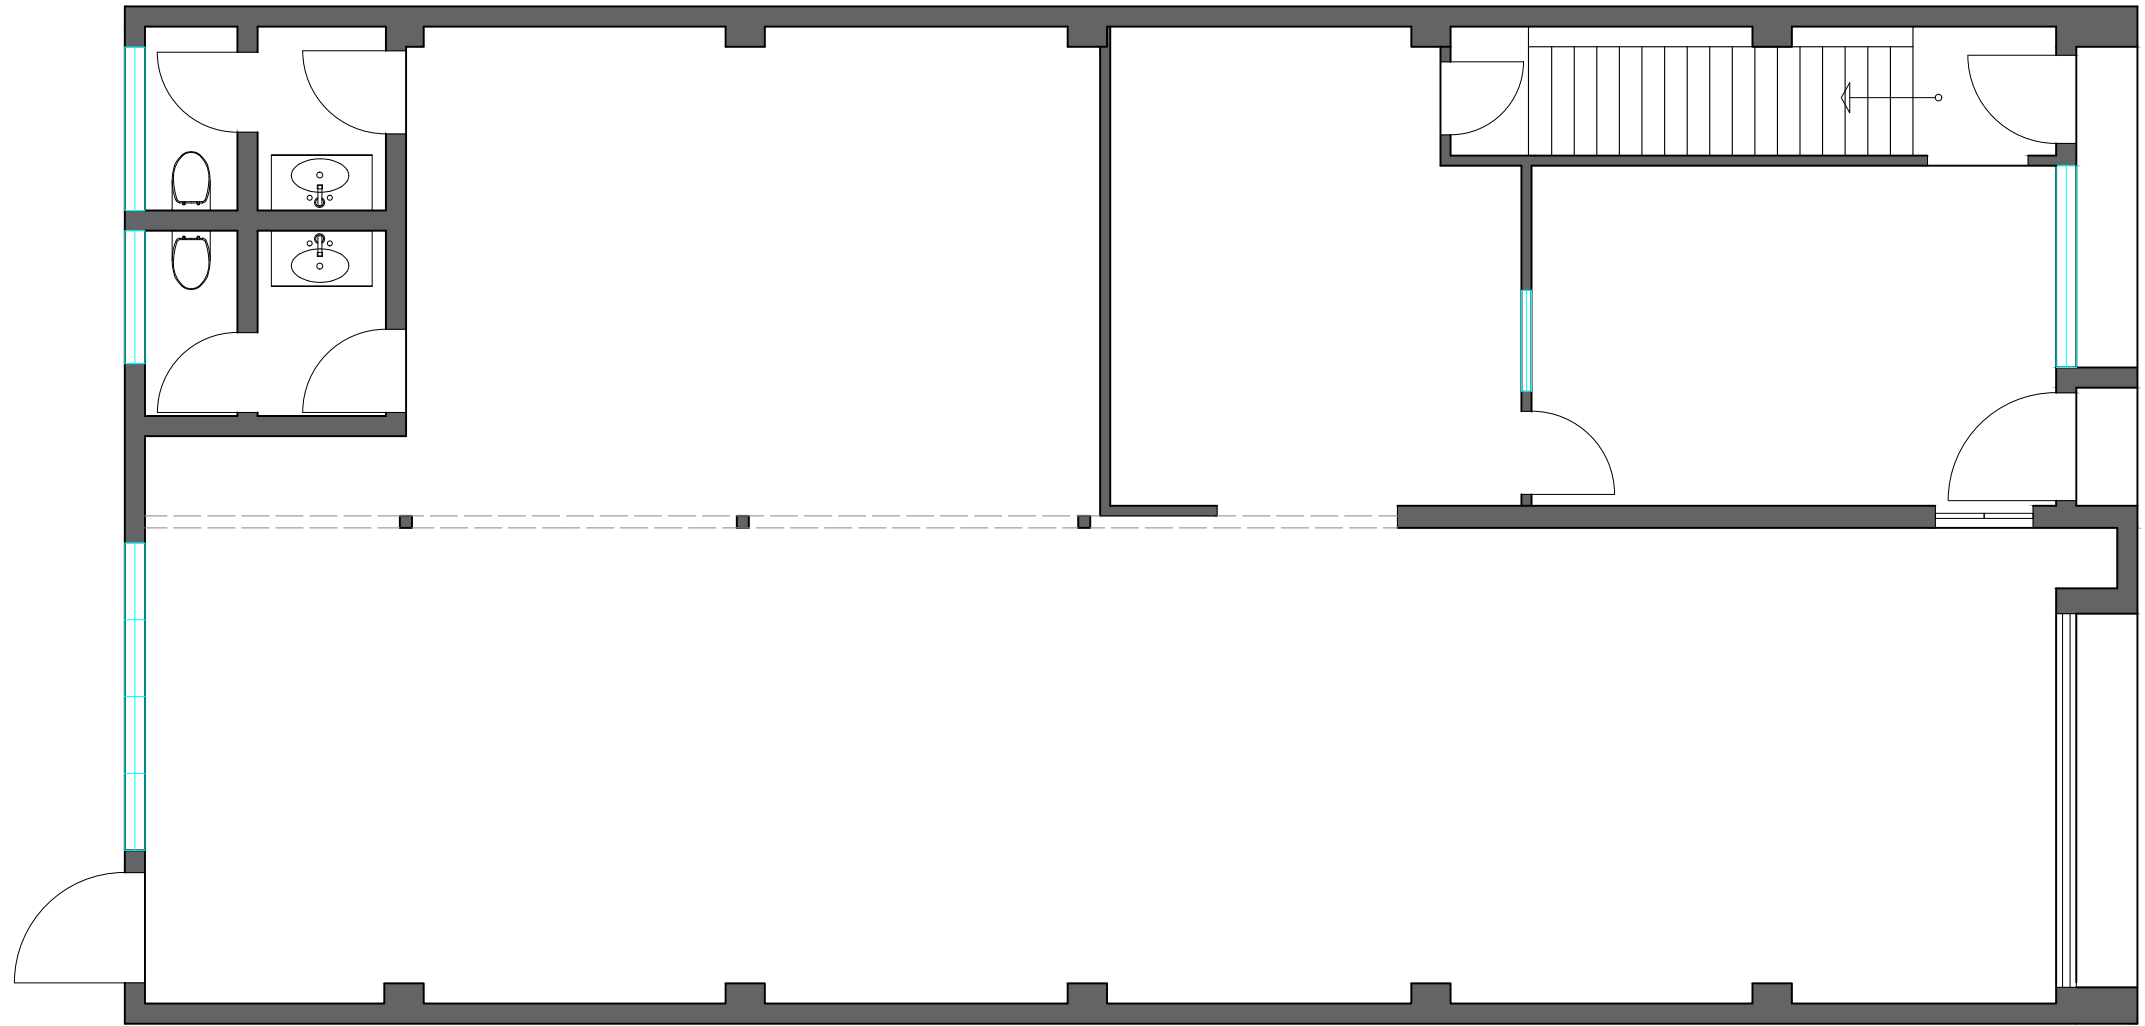

## EXISTING FLOOR PLAN GROUND LEVEL

SCALE 1:75

- THESE PLANS REMAIN THE PROPERTY OF IMPACT FITOUTS AND SHOULD NOT BE COPIED OR DISTRIBUTED WITHOUT PRIOR CONSENT. ALL DRAWINGS ARE SUBJECT TO COPYRIGHT LAWS.

- THESE PLANS ARE NOT TO BE USED FOR CONSTRUCTION PURPOSES AND ARE ONLY A GUIDELINE FOR THE SERVICES REQUIRED. EG- HYDRAULICS, LIGHTING, ELECTRICAL, ETC.

- ONLY WRITTEN MEASUREMENTS SHOULD BE CONSIDERED. DO NOT SCALE OFF THE PLANS. PLEASE CALL TO VERIFY DIMENSIONS IF YOU ARE UNSURE.

- PLANS DRAWN TO FIT ON A3 PAPER SIZE ONLY. EMAILED, PHOTOCOPIED, OR PDF FORMATTED DRAWINGS MAY NOT BE TO SCALE.

- CONTRACTORS SHOULD VERIFY SITE MEASUREMENTS AND CONDITIONS BEFORE STARTING WORKS. ALL WORKS TO COMPLY WITH THE RELEVANT AUSTRALIAN STANDARDS AND THE RELEVANT LOCAL AUTHORITY LAWS.

- DRAWINGS SUBJECT TO CHANGE AT ANYTIME WITHOUT NOTIFICATION.

REVISIONS:			
DATE:	ISSUE:	AMENDMENT:	APPROVED BY:

SCALE: NTS ON A3 PAPER ONLY  
 DRAWN BY: LD DATE: 11-12-2025


CLIENT:	CLANDESTINE DESIGN GROUP
PROJECT:	CLANDESTINE DESIGN GROUP
SITE ADDRESS:	27 BALACLAVA STREET WOOLLOONGABBA BRISBANE QLD 4102
TITLE:	EXISTING FLOOR PLAN GROUND LEVEL



E : [info@impactfitouts.com.au](mailto:info@impactfitouts.com.au)  
 P: 0413 530 560

DRAWING NO:	CDG-101	ISSUE:	01
-------------	---------	--------	----

**BCC DS**  
**RECEIVED**  
 25/06/2026  
**APPLICATION REF**  
 A006967005

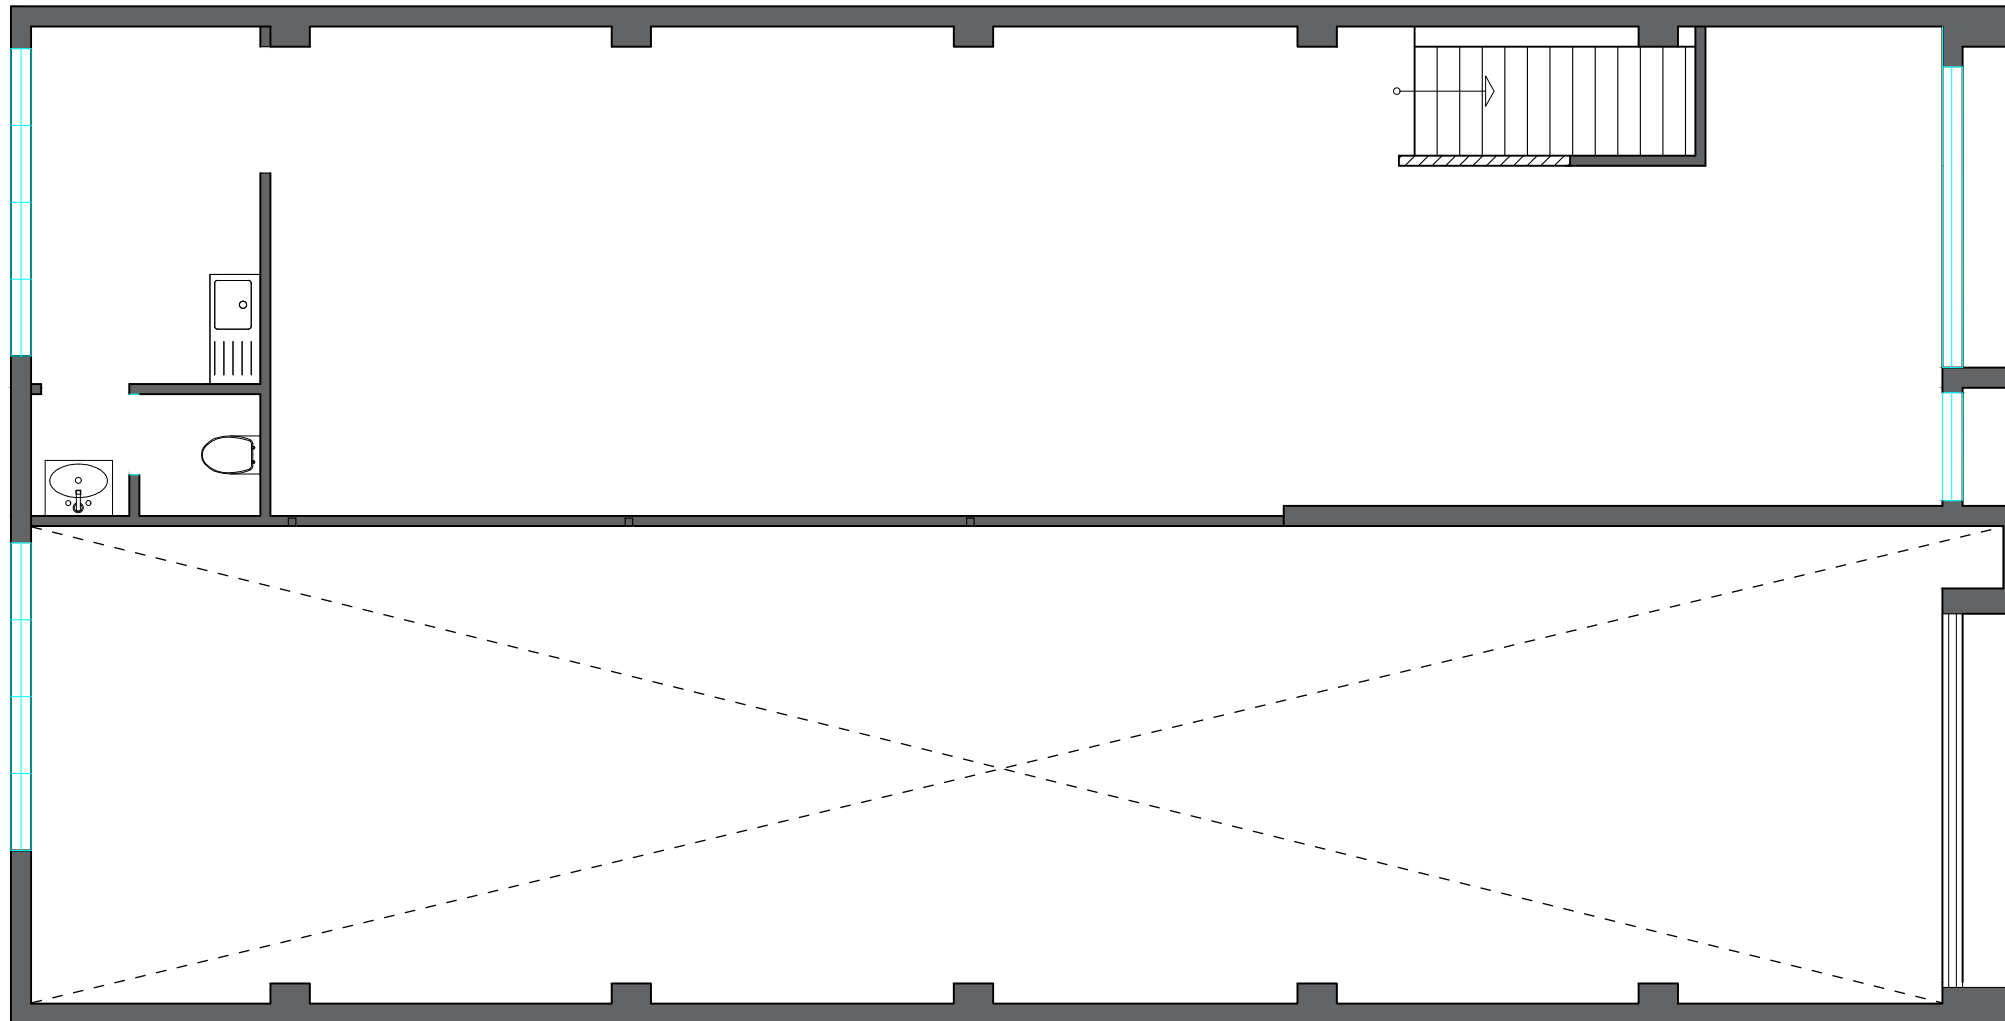

**EXISTING FLOOR PLAN LEVEL 1**  
 SCALE 1:75

- THESE PLANS REMAIN THE PROPERTY OF IMPACT FITOUTS AND SHOULD NOT BE COPIED OR DISTRIBUTED WITHOUT PRIOR CONSENT. ALL DRAWINGS ARE SUBJECT TO COPYRIGHT LAWS.

- THESE PLANS ARE NOT TO BE USED FOR CONSTRUCTION PURPOSES AND ARE ONLY A GUIDELINE FOR THE SERVICES REQUIRED. EG- HYDRAULICS, LIGHTING, ELECTRICAL, ETC.

- ONLY WRITTEN MEASUREMENTS SHOULD BE CONSIDERED. DO NOT SCALE OFF THE PLANS. PLEASE CALL TO VERIFY DIMENSIONS IF YOU ARE UNSURE.

- PLANS DRAWN TO FIT ON A3 PAPER SIZE ONLY. EMAILED, PHOTOCOPIED, OF PDF FORMATTED DRAWINGS MAY NOT BE TO SCALE.

- CONTRACTORS SHOULD VERIFY SITE MEASUREMENTS AND CONDITIONS BEFORE STARTING WORKS. ALL WORKS TO COMPLY WITH THE RELEVANT AUSTRALIAN STANDARDS AND THE RELEVANT LOCAL AUTHORITY LAWS.

- DRAWINGS SUBJECT TO CHANGE AT ANYTIME WITHOUT NOTIFICATION.

REVISIONS:			
DATE:	ISSUE:	AMENDMENT:	APPROVED BY:

SCALE: NTS ON A3 PAPER ONLY

DRAWN BY: LD      DATE: 11-12-2025

CLIENT:	CLANDESTINE DESIGN GROUP
PROJECT:	CLANDESTINE DESIGN GROUP
SITE ADDRESS:	27 BALACLAVA STREET WOOLLOONGABBA BRISBANE QLD 4102
TITLE:	EXISTING FLOOR PLAN LEVEL 1




E : [info@impactfitouts.com.au](mailto:info@impactfitouts.com.au)  
 P: 0413 530 560

DRAWING NO:	CDG-102	ISSUE:	01
-------------	---------	--------	----





**BCC DS**  
**RECEIVED**  
 25/06/2026  
**APPLICATION REF**  
 A006967005

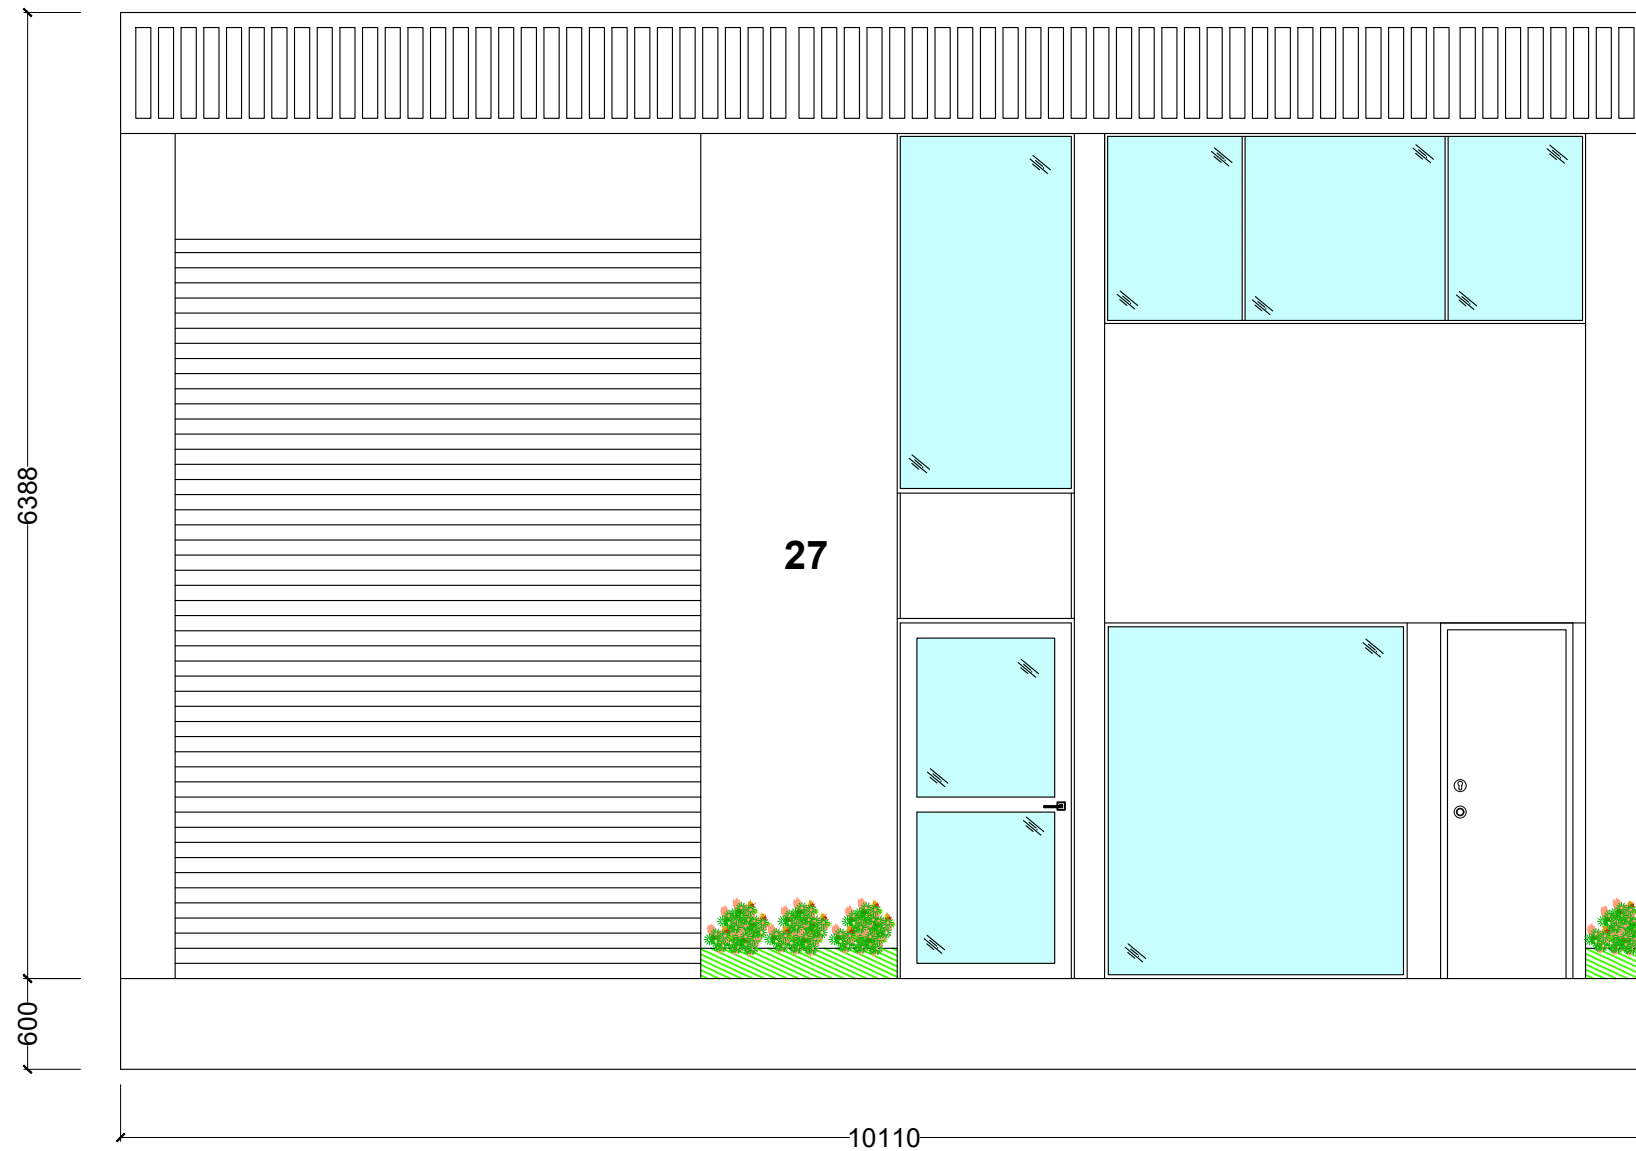

**FRONT ELEVATION**  
SCALE 1:50

- THESE PLANS REMAIN THE PROPERTY OF IMPACT FITOUTS AND SHOULD NOT BE COPIED OR DISTRIBUTED WITHOUT PRIOR CONSENT. ALL DRAWINGS ARE SUBJECT TO COPYRIGHT LAWS.

- THESE PLANS ARE NOT TO BE USED FOR CONSTRUCTION PURPOSES AND ARE ONLY A GUIDELINE FOR THE SERVICES REQUIRED. EG- HYDRAULICS, LIGHTING, ELECTRICAL, ETC.

- ONLY WRITTEN MEASUREMENTS SHOULD BE CONSIDERED. DO NOT SCALE OFF THE PLANS. PLEASE CALL TO VERIFY DIMENSIONS IF YOU ARE UNSURE.

- PLANS DRAWN TO FIT ON A3 PAPER SIZE ONLY. EMAILED, PHOTOCOPIED, OF PDF FORMATTED DRAWINGS MAY NOT BE TO SCALE.

- CONTRACTORS SHOULD VERIFY SITE MEASUREMENTS AND CONDITIONS BEFORE STARTING WORKS. ALL WORKS TO COMPLY WITH THE RELEVANT AUSTRALIAN STANDARDS AND THE RELEVANT LOCAL AUTHORITY LAWS.

- DRAWINGS SUBJECT TO CHANGE AT ANYTIME WITHOUT NOTIFICATION.

REVISIONS:			
DATE:	ISSUE:	AMENDMENT:	APPROVED BY:
SCALE: NTS ON A3 PAPER ONLY			
DRAWN BY: LD	DATE: 11-02-2026		


CLIENT:	CLANDESTINE DESIGN GROUP
PROJECT:	CLANDESTINE DESIGN GROUP
SITE ADDRESS:	27 BALACLAVA STREET WOOLLOONGABBA BRISBANE QLD 4102
TITLE:	FRONT ELEVATION



E : [info@impactfitouts.com.au](mailto:info@impactfitouts.com.au)  
P: 0413 530 560

DRAWING NO: CDG-104	ISSUE: 01
---------------------	-----------

**BCC DS**  
**RECEIVED**  
 25/06/2026  
**APPLICATION REF**  
 A006967005

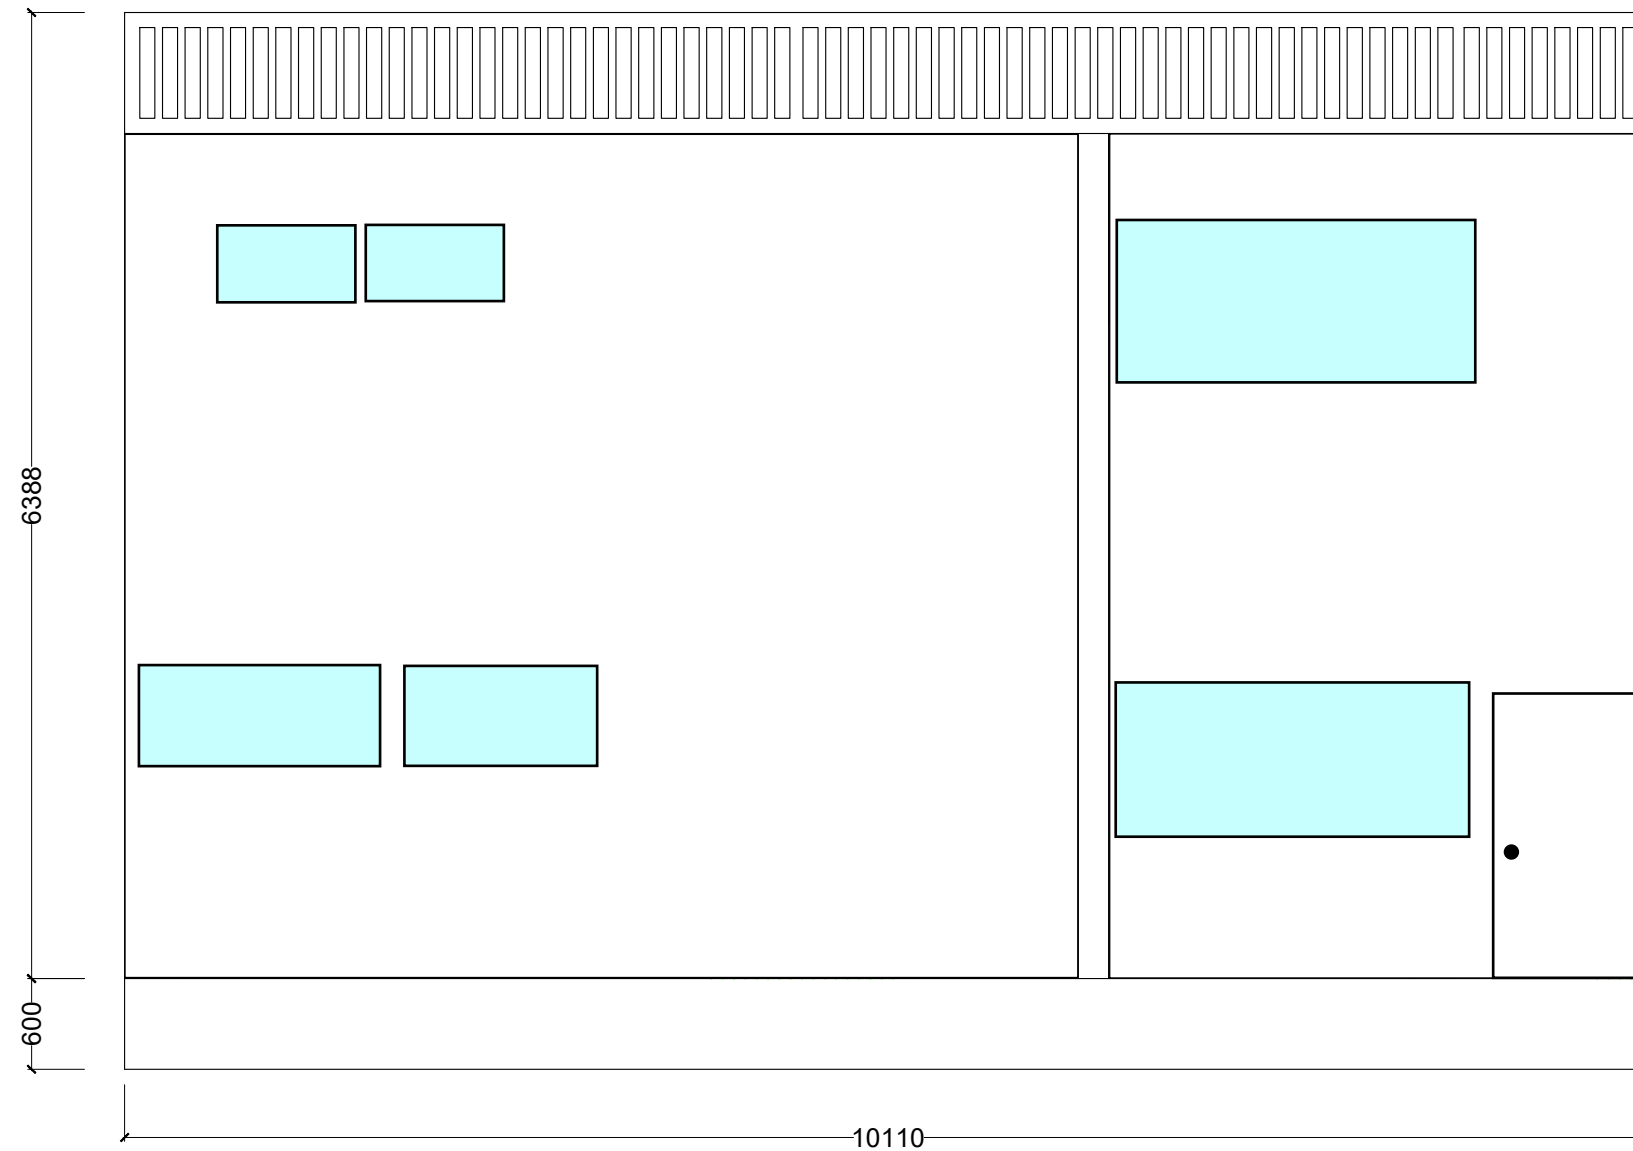

# REAR ELEVATION

SCALE 1:50

- THESE PLANS REMAIN THE PROPERTY OF IMPACT FITOUTS AND SHOULD NOT BE COPIED OR DISTRIBUTED WITHOUT PRIOR CONSENT. ALL DRAWINGS ARE SUBJECT TO COPYRIGHT LAWS.

- THESE PLANS ARE NOT TO BE USED FOR CONSTRUCTION PURPOSES AND ARE ONLY A GUIDELINE FOR THE SERVICES REQUIRED. EG- HYDRAULICS, LIGHTING, ELECTRICAL, ETC.

- ONLY WRITTEN MEASUREMENTS SHOULD BE CONSIDERED. DO NOT SCALE OFF THE PLANS. PLEASE CALL TO VERIFY DIMENSIONS IF YOU ARE UNSURE.

- PLANS DRAWN TO FIT ON A3 PAPER SIZE ONLY. EMAILED, PHOTOCOPIED, OF PDF FORMATTED DRAWINGS MAY NOT BE TO SCALE.

- CONTRACTORS SHOULD VERIFY SITE MEASUREMENTS AND CONDITIONS BEFORE STARTING WORKS. ALL WORKS TO COMPLY WITH THE RELEVANT AUSTRALIAN STANDARDS AND THE RELEVANT LOCAL AUTHORITY LAWS.

- DRAWINGS SUBJECT TO CHANGE AT ANYTIME WITHOUT NOTIFICATION.

REVISIONS:			
DATE:	ISSUE:	AMENDMENT:	APPROVED BY:

SCALE: NTS ON A3 PAPER ONLY

DRAWN BY: LD      DATE: 11-02-2026

CLIENT:	CLANDESTINE DESIGN GROUP
PROJECT:	CLANDESTINE DESIGN GROUP
SITE ADDRESS:	27 BALACLAVA STREET WOOLLOONGABBA BRISBANE QLD 4102
TITLE:	REAR ELEVATION



E : [info@impactfitouts.com.au](mailto:info@impactfitouts.com.au)

P: 0413 530 560

DRAWING NO:	CDG-104	ISSUE:	01
-------------	---------	--------	----