
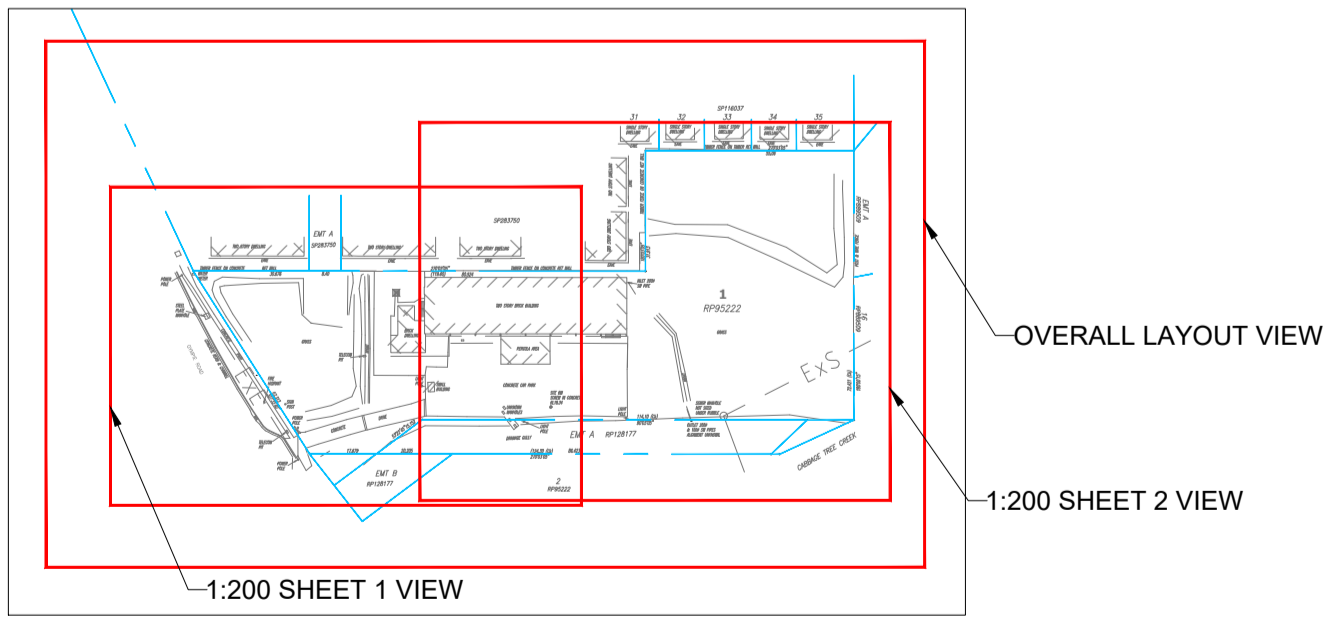


**BCC DS**  
**RECEIVED**  
 25/06/2026  
**APPLICATION REF**  
 A006743613

LEGEND	
	EXISTING BOUNDARY
	EXISTING CONTOURS (AT 0.2m INTERVALS)
	PROPOSED FINISHED CONTOURS (AT 0.2m INTERVALS)
	PROPOSED RETAINING WALL
	EXISTING SEWER RETICULATION
	PROPOSED STORMWATER
	TYPE B2 BARRIER KERB
	PROPOSED ROAD
	PROPOSED CONCRETE FOOTPATH
	PROPOSED LANDSCAPING
	PROPOSED BUILDING
	DEVELOPMENT SWALE
	PROPOSED STORM STRUCTURE NAME

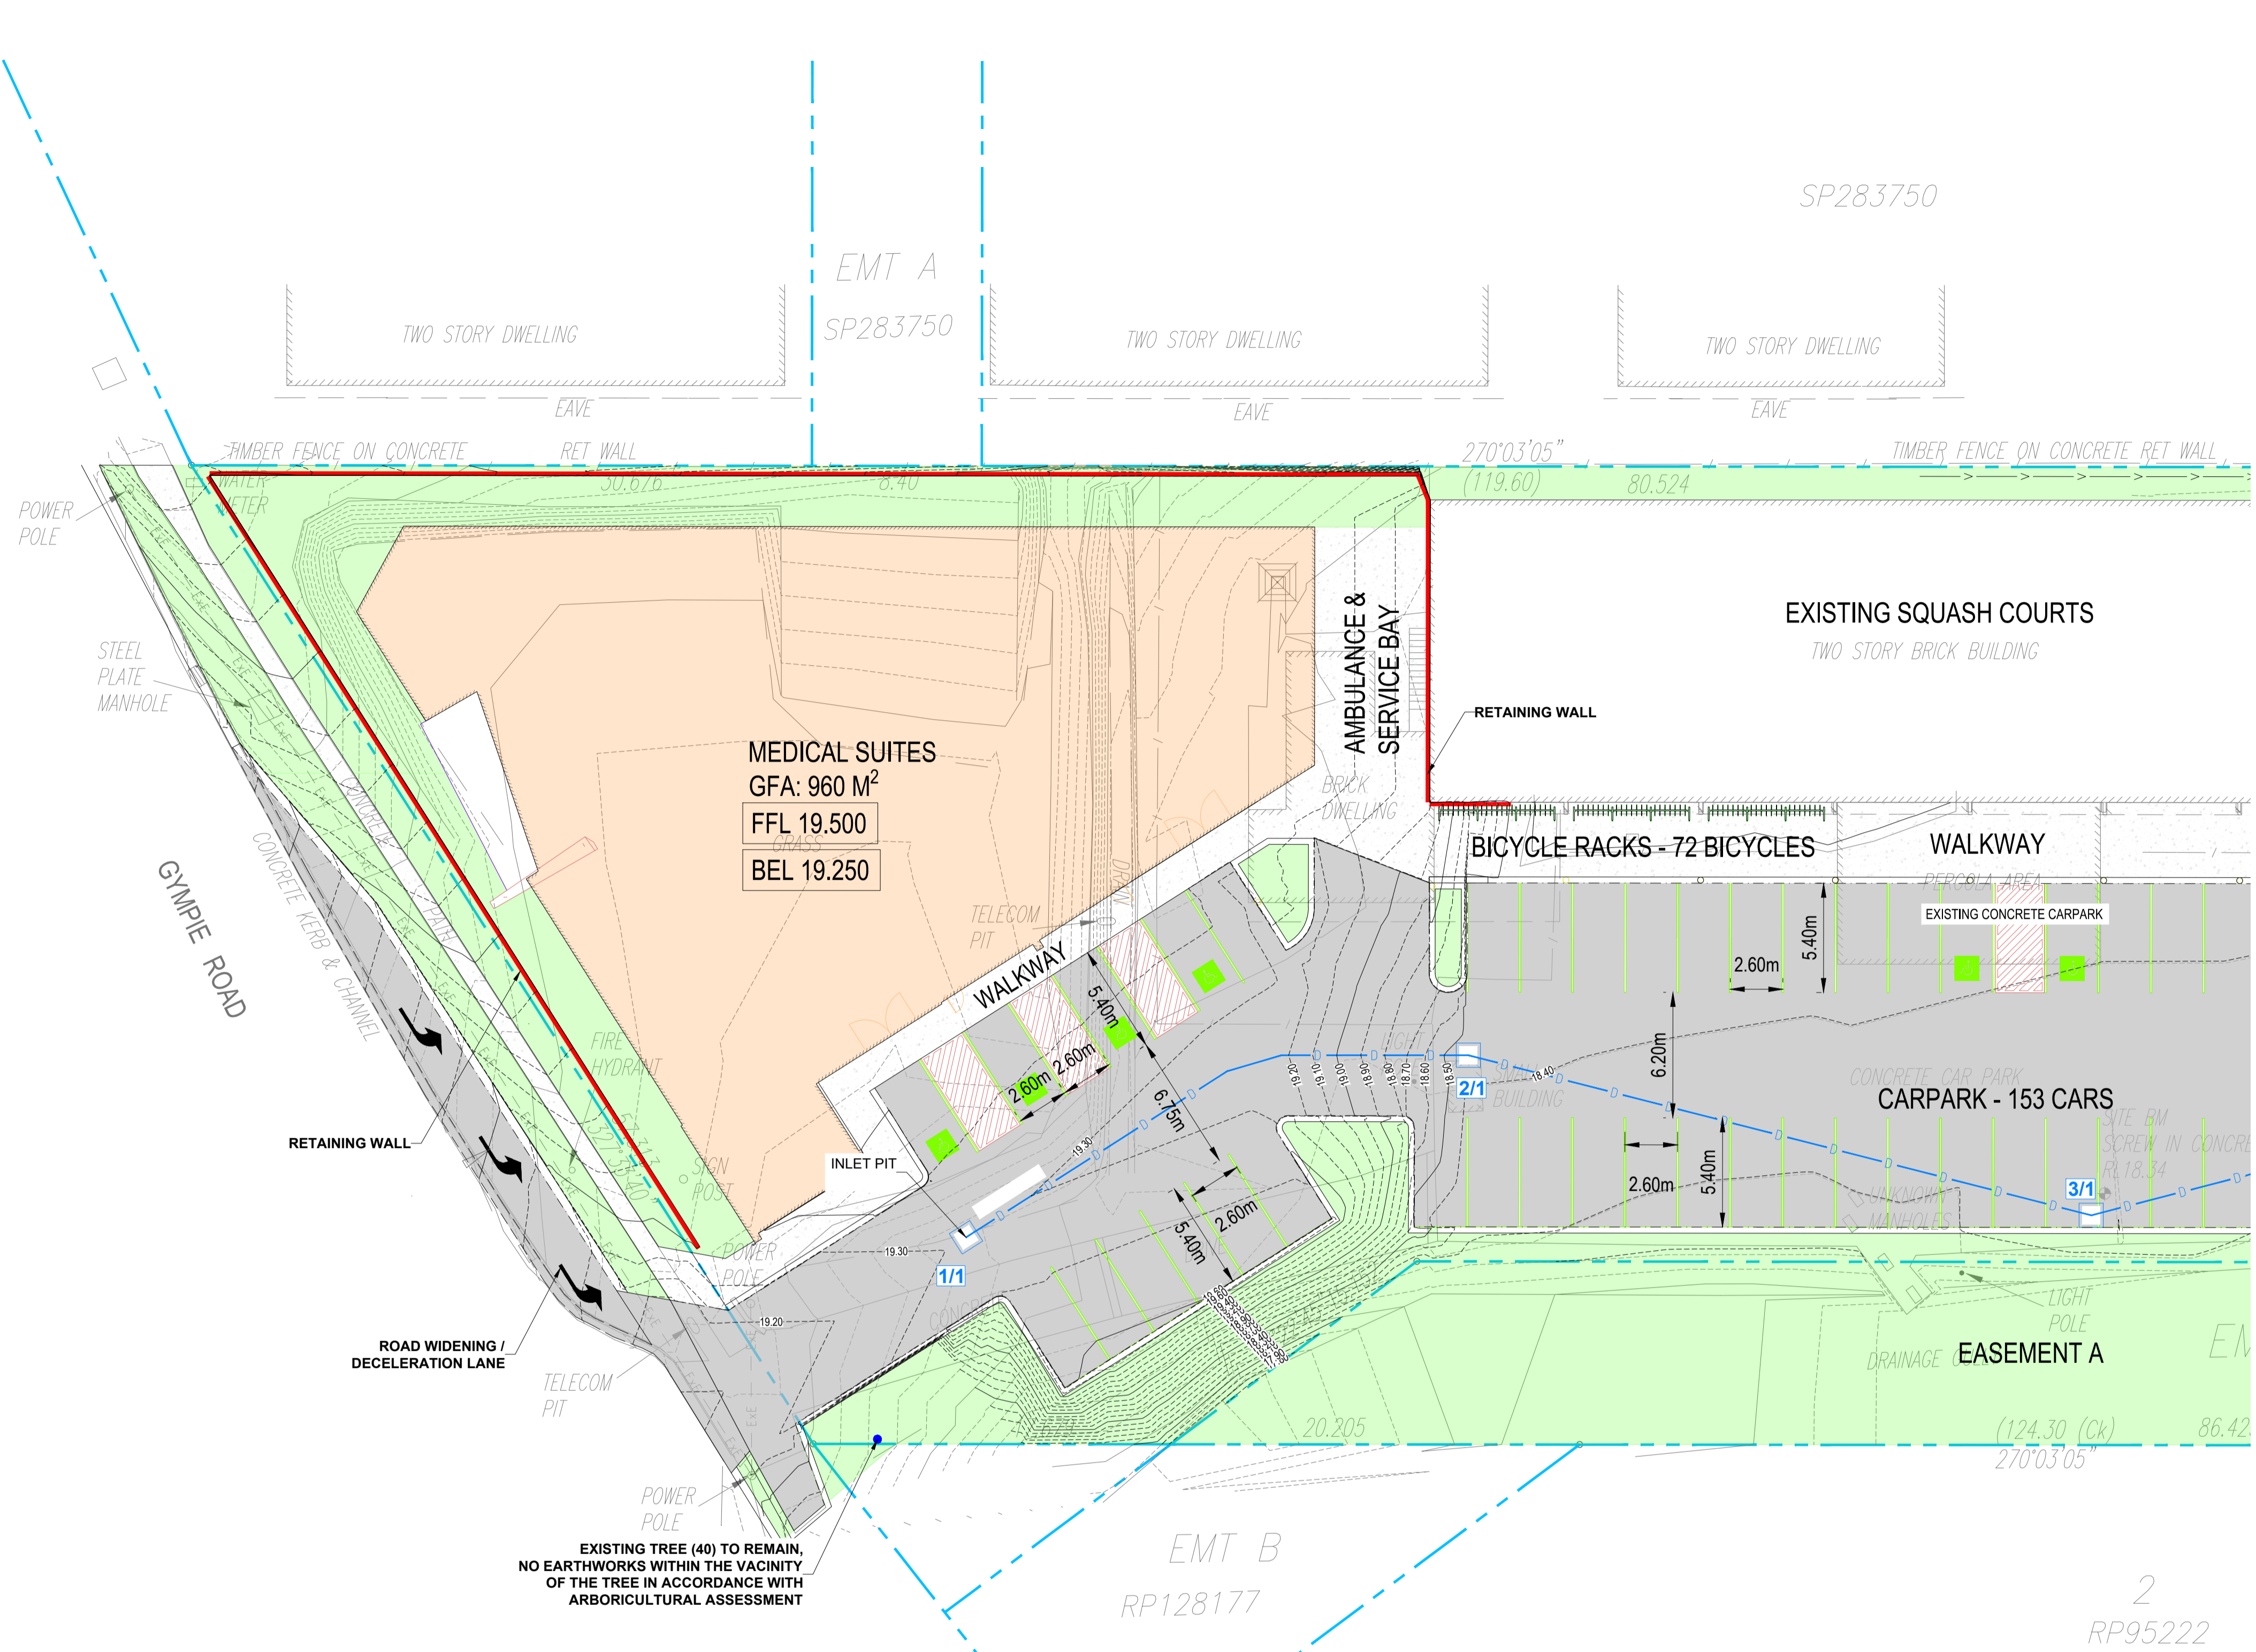

REVISIONS:	
No.	REVISION DESCRIPTION
A	ISSUED FOR APPROVED

**DCD CONSULTING**  
 DESIGN • CONSTRUCT • DEVELOP

PHONE: 0423141818  
 EMAIL: ADMIN@DCDCONSULTING.COM.AU  
 WEB: WWW.DCCONSULTING.COM.AU

DISCLAIMER: THIS DRAWING AND ALL ASSOCIATED CONTENT HAVE BEEN GENERATED ELECTRONICALLY. ANY CHANGES, ALTERATIONS, AND/OR REVISIONS SHALL BE THE RESPONSIBILITY OF THE CLIENT. THE CLIENT ACCEPTS AND AGREES TO BE RESPONSIBLE FOR ANY OUTCOMES RESULTING FROM USE OUTSIDE THE INTENDED PURPOSE, OR WHERE THE DRAWING IS USED FOR ANY OTHER PURPOSE.

SCALE BAR  
 0 1 2 3 4 5 10m 15 20m  
 SCALE 1:200

DATUM

CLIENT  
**VICTOR SECURITY PTY LTD**  
 1545 GYMPIE ROAD  
 CARSELDINE, QLD 4034

ARCHITECT

PROJECT TITLE  
**PROPOSED MEDICAL CENTRE**  
 1545 GYMPIE ROAD  
 CARSELDINE, QLD 4034

DRAWING TITLE  
**ROAD WORKS AND DRAINAGE LAYOUT SHEET 1**

DRAWING STATUS <b>FOR APPROVED</b>		NORTHPOINT 	
NOT TO BE USED FOR CONSTRUCTION		SIGNATURE	
DRAWN CP	DESIGNER GD	SCALE 1:200 AT A1	
JOB No. 25054		DRAWING No. C301	
SHEET SIZE A1		REVISION	

